


DRAINAGE LAYOUT TO BE CONFIRMED FOLLOWING DISCUSSION WITH LPA 28.01.22

 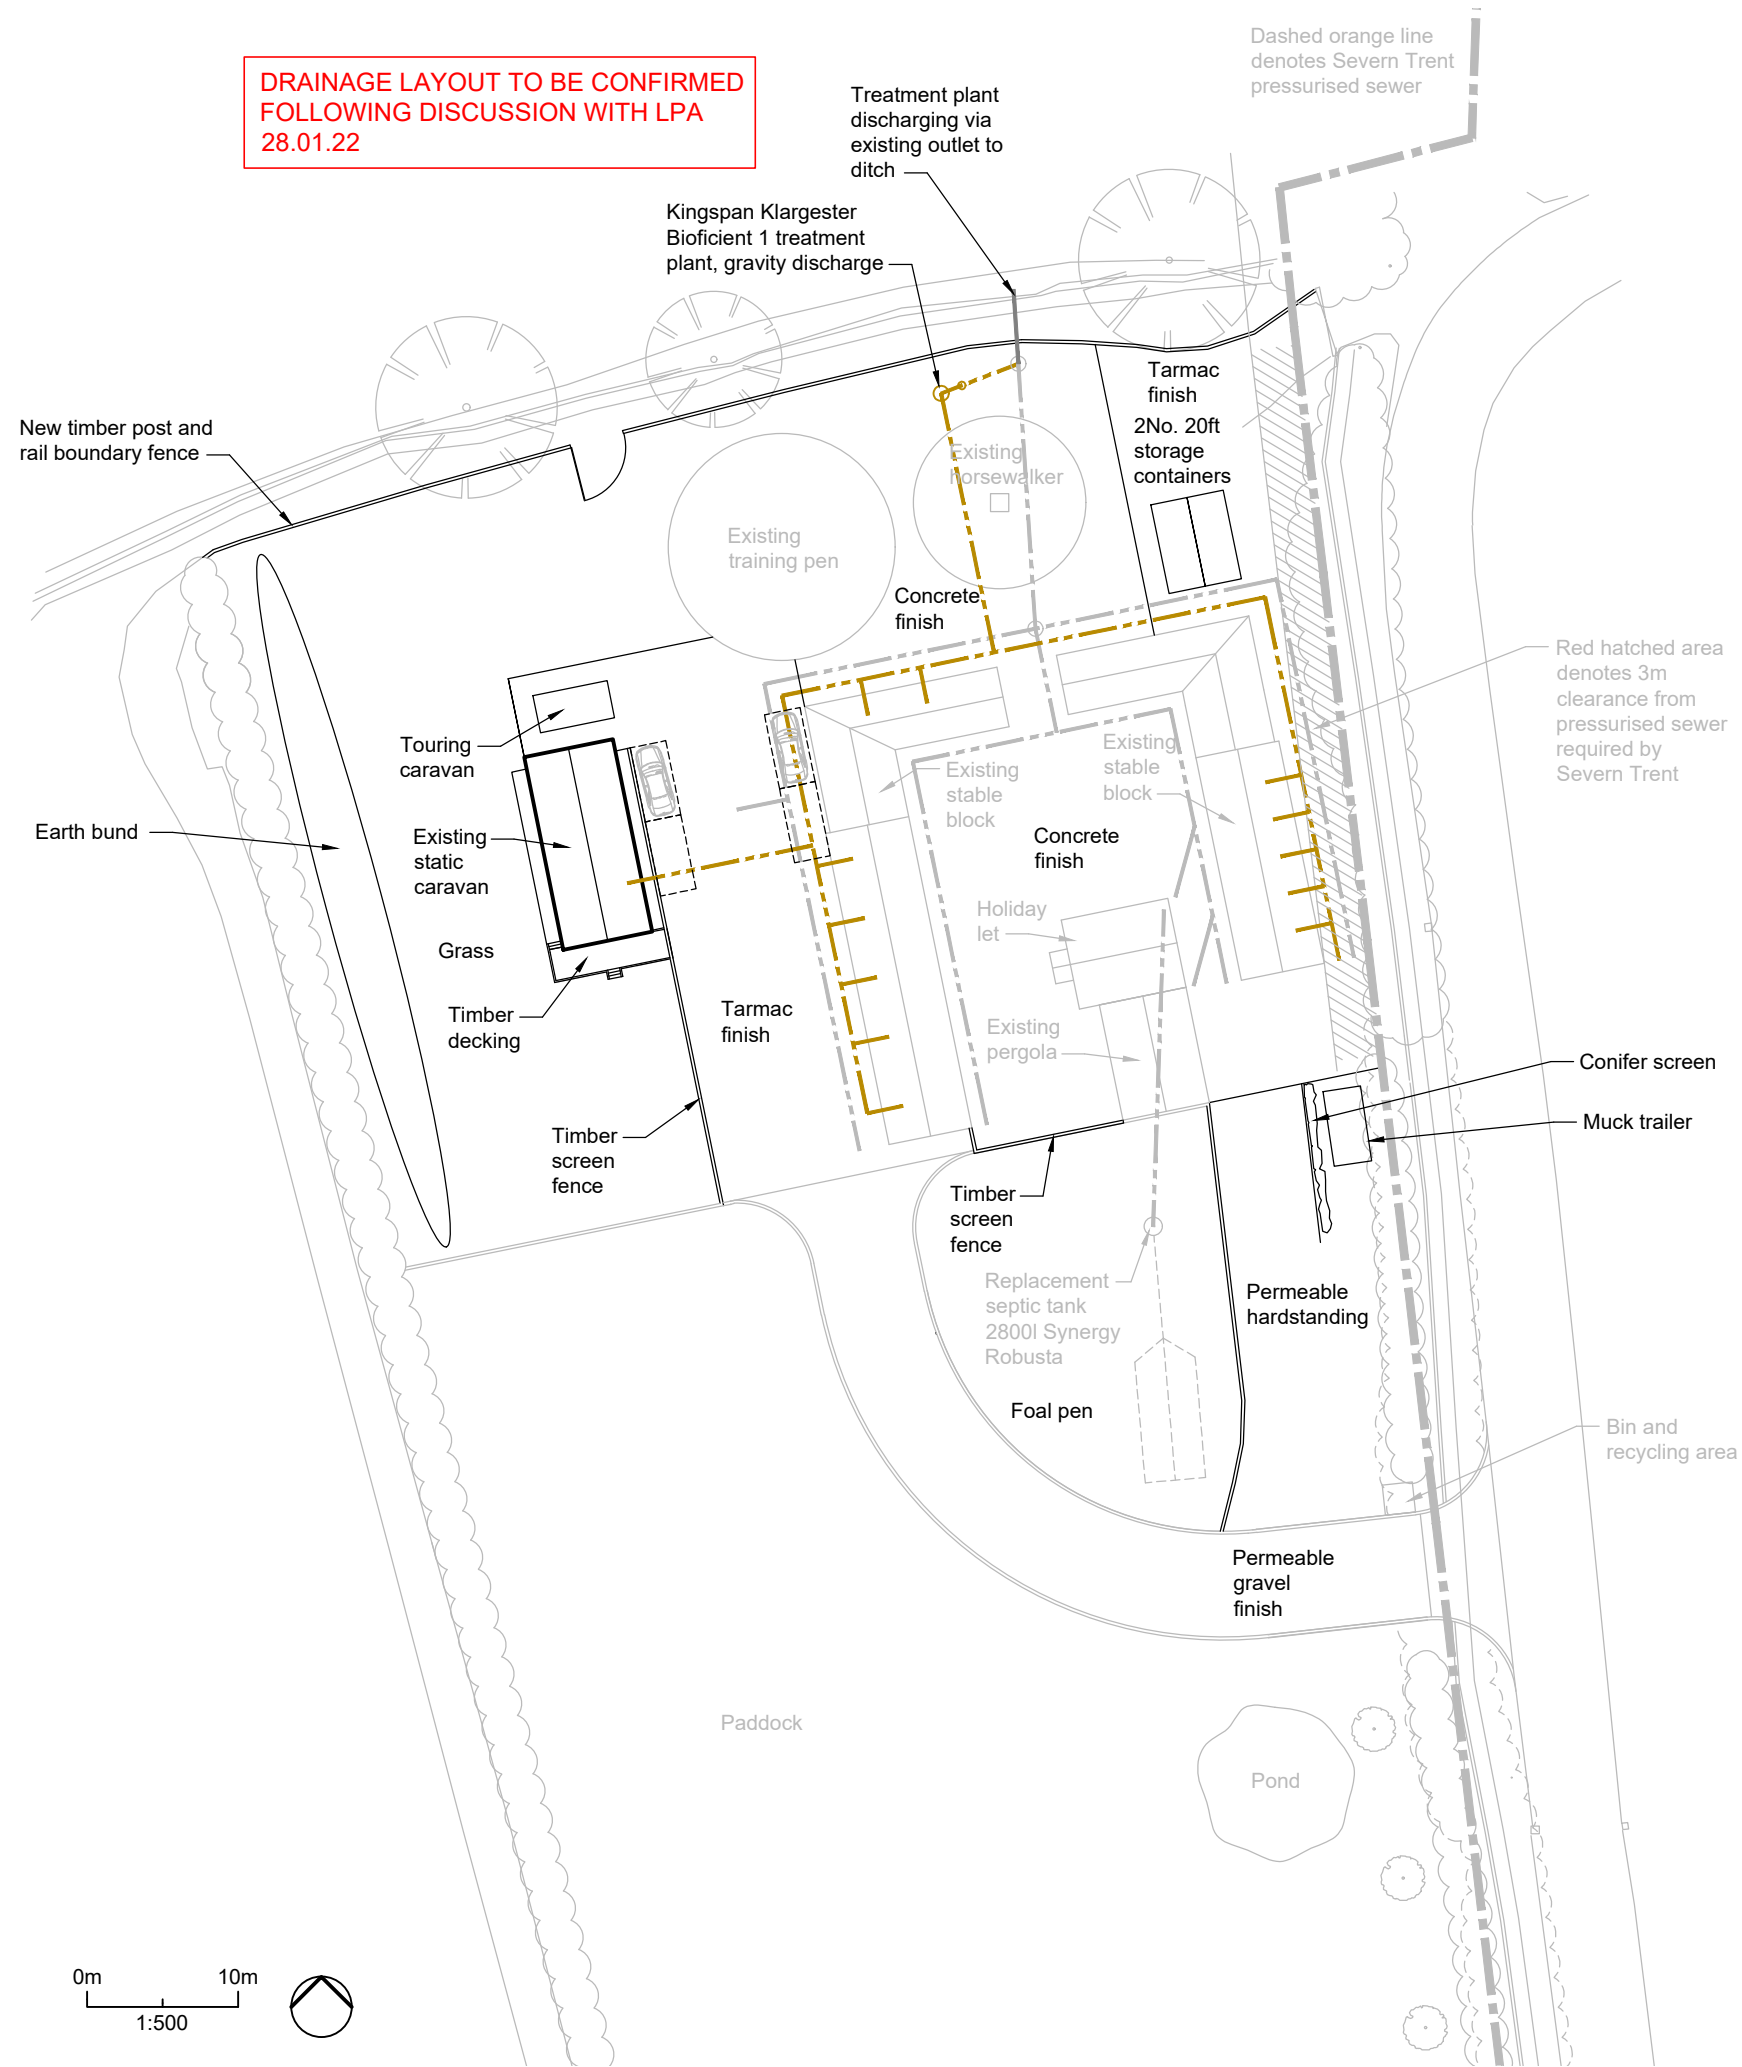


Red line denotes site outline
Blue line denotes additional land owned by Client

NOTES
 Drawing for planning only
 All measurements to be checked on site

Revision	Description	Date

project	RUSHMOOR
project no.	1290
client	MR EVANS
drawing	PROPOSED SITE PLAN (RETROSPECTIVE)
drawing no.	revision
08	-
status	PLANNING
scale	date
1:500@A3	25.01.22
drawn by	AB



MOSS. CO. LLP.
 BROOKGATE HALL - PLEALEY - SHREWSBURY - SY5 0UY
 Tel: 01743 588230
 E-mail: info@mosscompany.co.uk